


NOTES: (PER ADOPTED UNIFORM PLUMBING CODE (UPC))

- 1. ALL COLD WATER PLUMBING PIPES TO BE SCHEDULE 40 PVC.
- 2. ALL HOT WATER PLUMBING PIPES TO BE SCHEDULE 40 CPVC.
- 3. ALL DRAINS ARE 3" EXCEPT NOTED OTHERWISE.

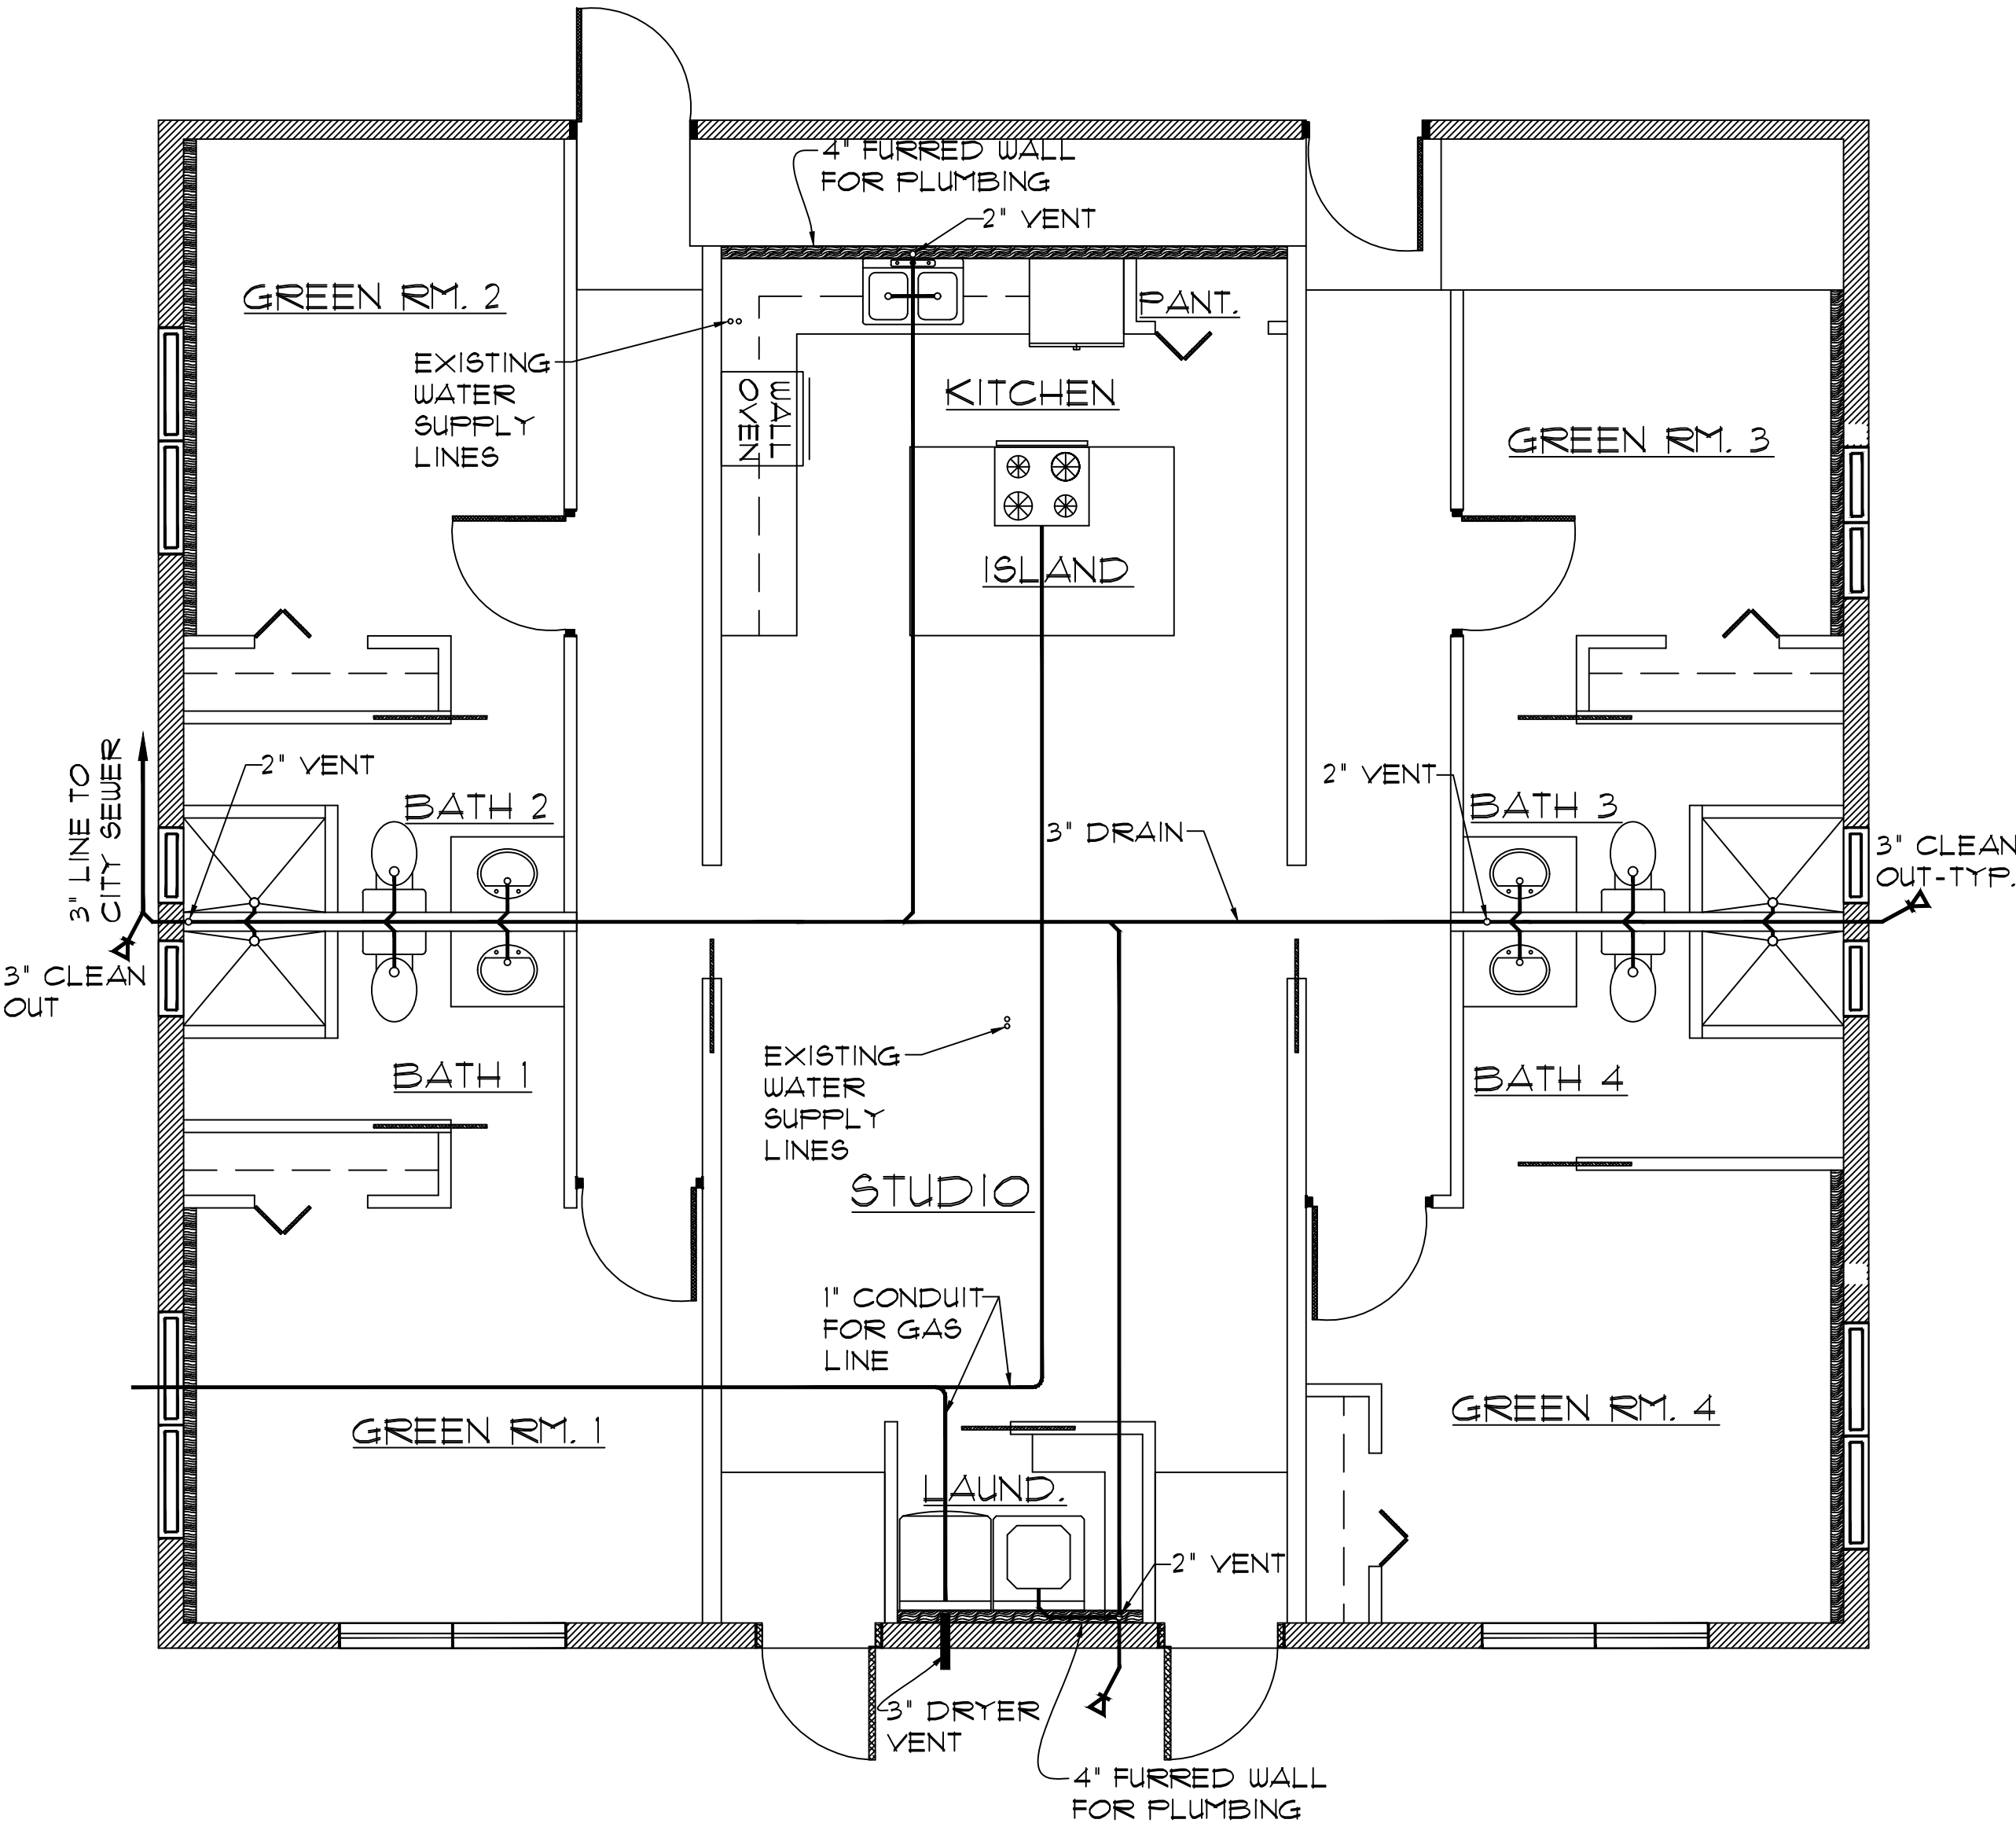

PLUMBING PLAN  
SCALE: 1/4" = 1'-0"

DATE: SEPT., 2024  
SCALE: 1/4" = 1'-0"  
DRAWN BY:  
JOB No.: 549  
SHEET No.: