


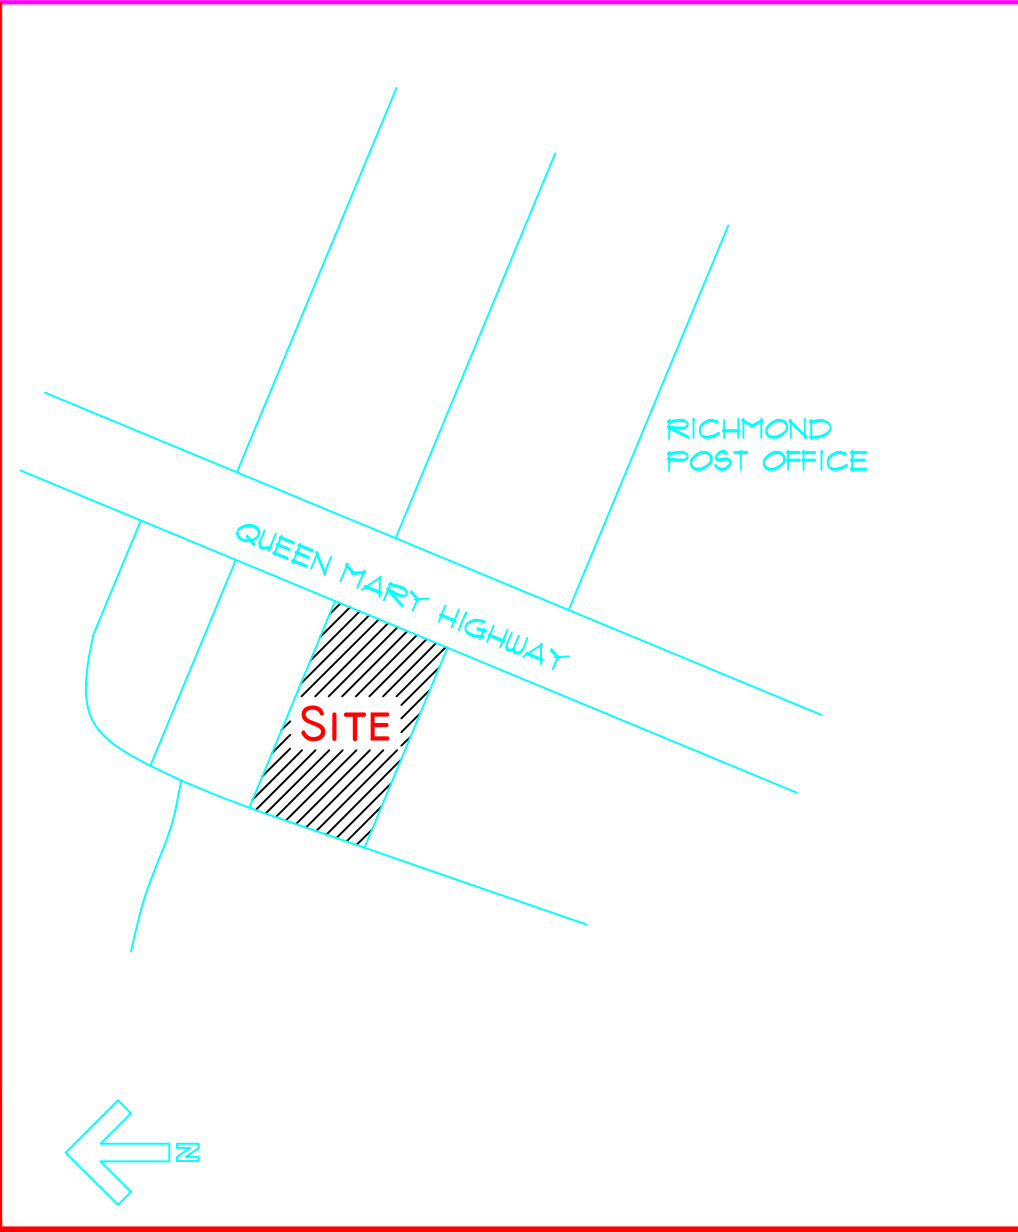


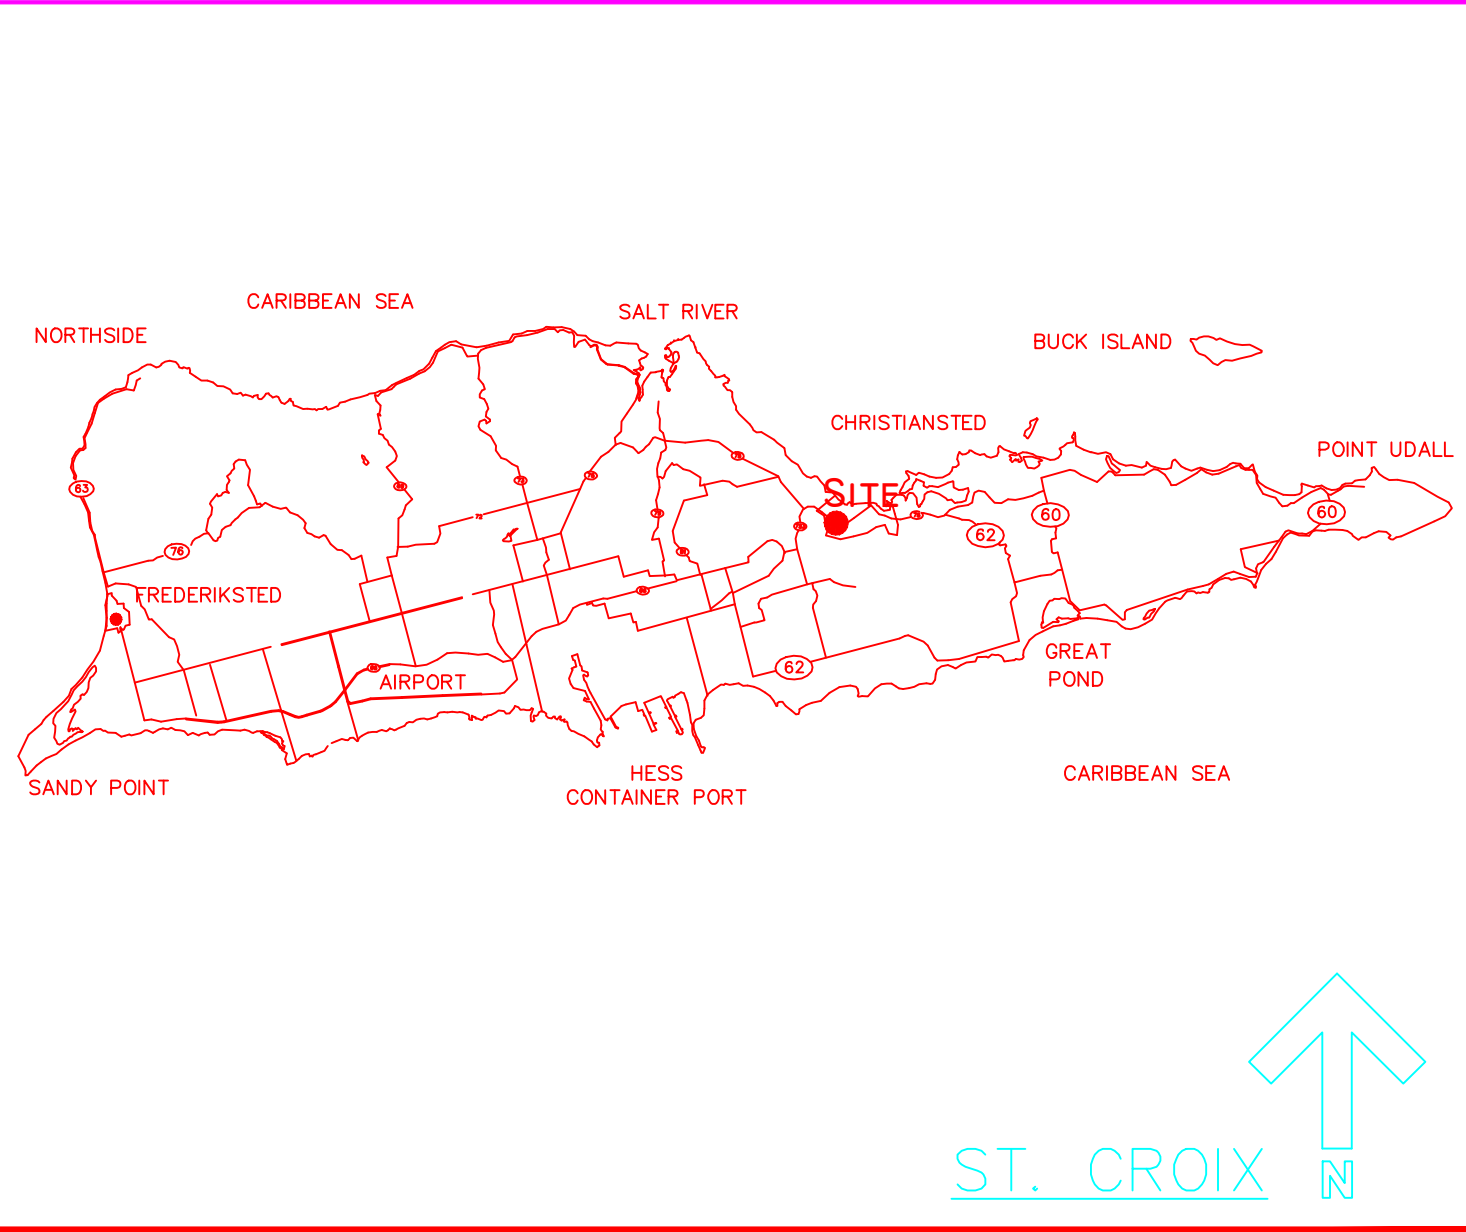

Site Location Map

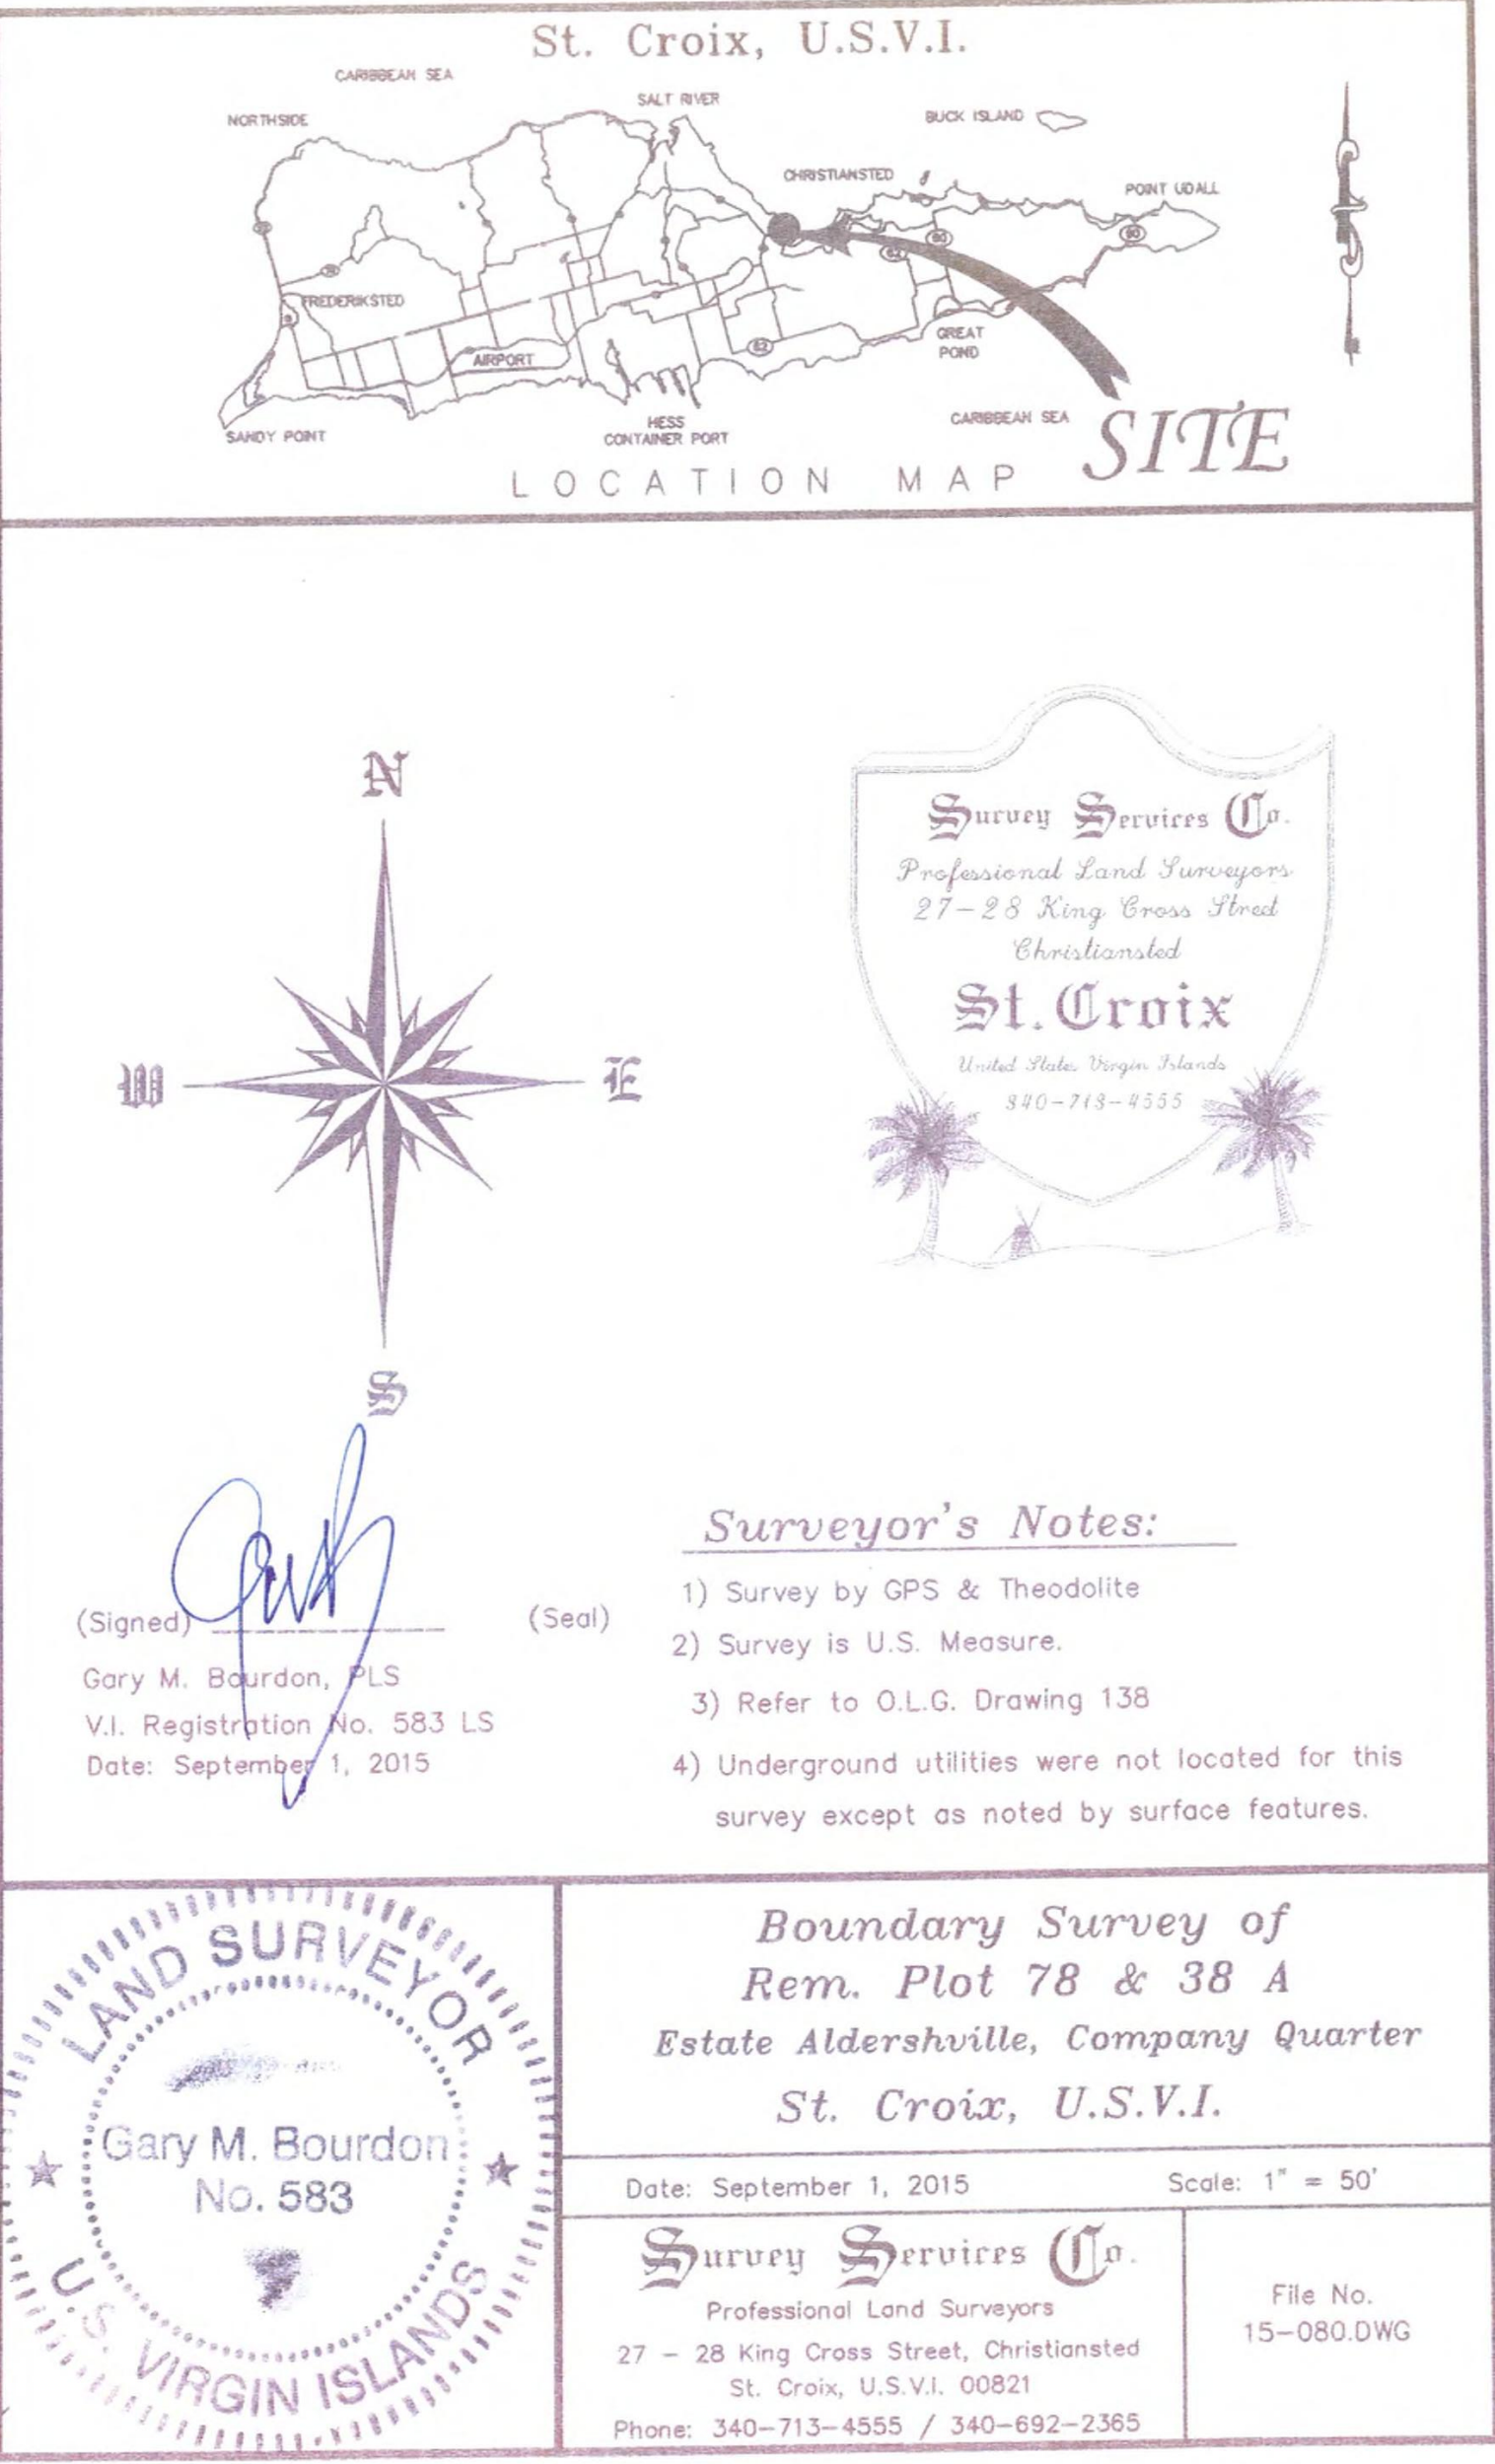

Site Vicinity Map

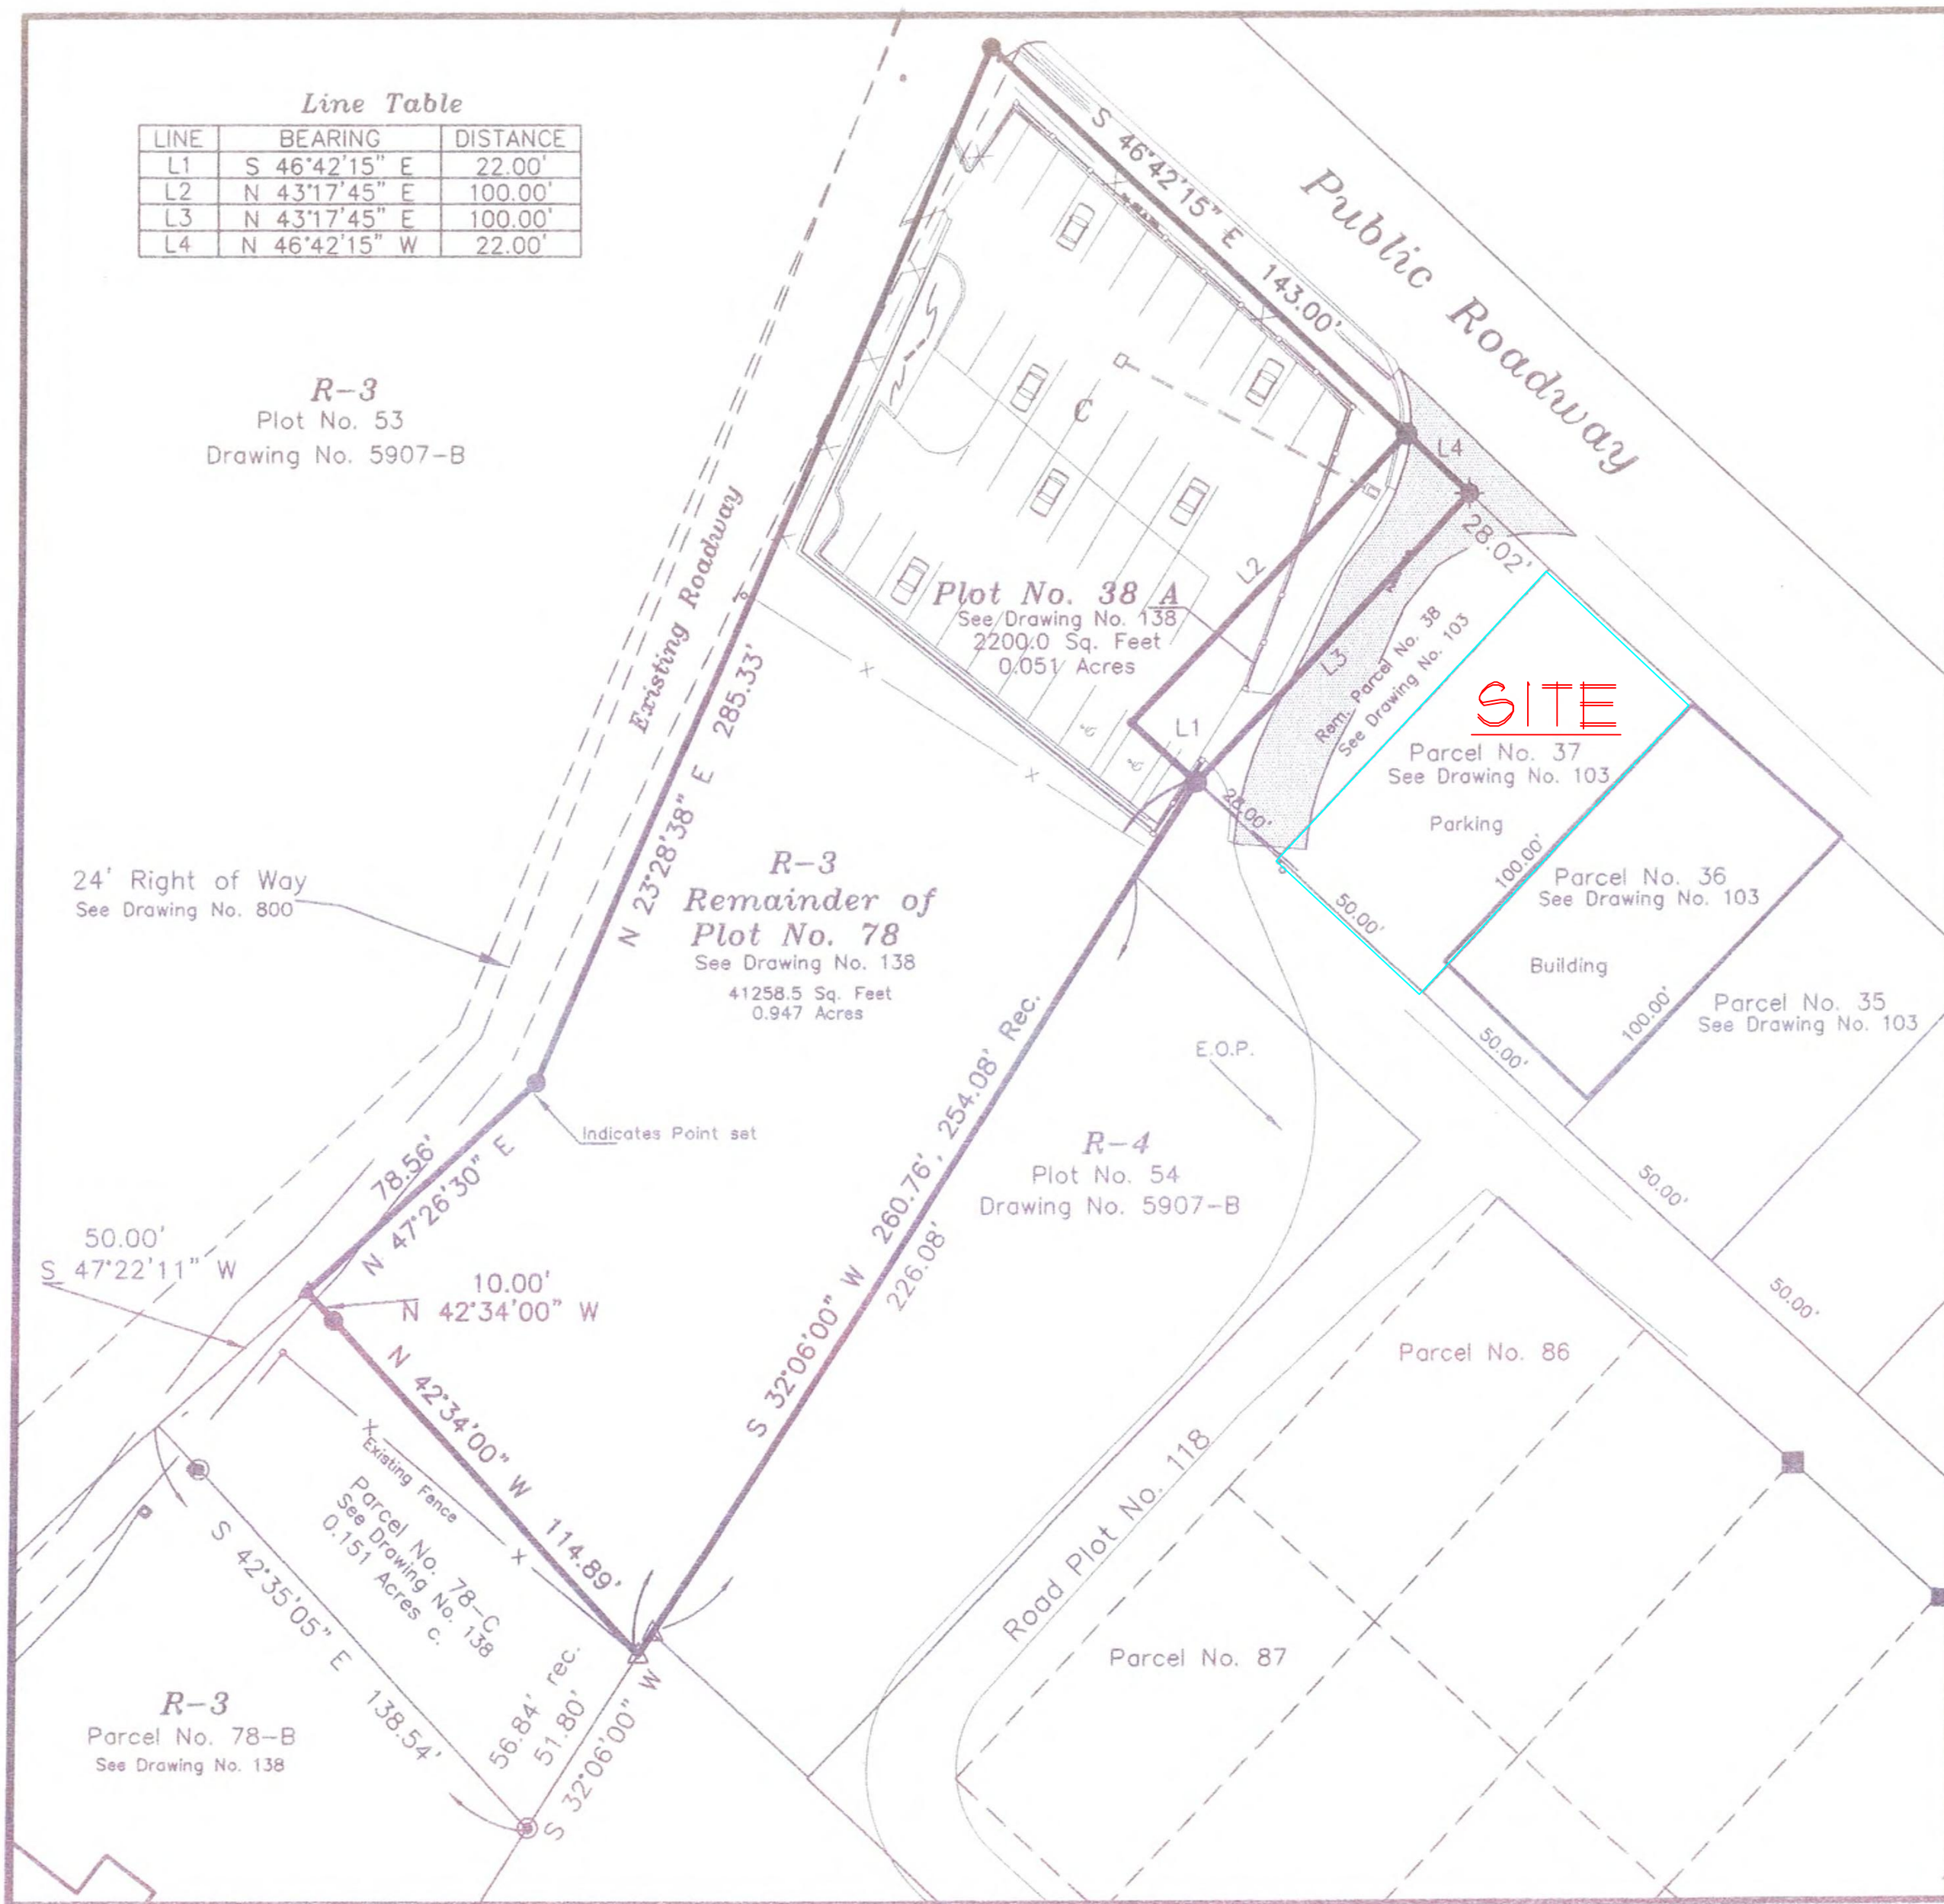

DRAWING INDEX

SITE PLAN	SP 1
FLOOR PLANS	A 1
FLOOR FRAMING & CEILING TILE PLANS	A 2
ELECTRICAL PLAN	E 1
PLUMBING PLAN	P 1
DETAILS	D 1
NOTES	N 1

NOTES: THE CONTRACTOR SHALL BE RESPONSIBLE FOR VERIFYING ALL GRADES, LEVELS, DIMENSIONS AND CONDITIONS SHOWN ON THESE DRAWINGS.

TOTAL SQUARE FOOTAGE:	1643.0
SEPTIC CAPACITY:	EXISTING CITY SEWER
CISTERN CAPACITY:	EXISTING POTABLE WATER
LOT OCCUPANCY:	EXISTING
ROOF SQUARE FOOTAGE:	EXISTING
CUBIC YARDS REMOVED:	0
ZONE:	C

FWD. #103

PROPOSED INTERIOR STUDIO BUILD OUT FOR:
WTXJ-VI PUBLIC BROADCASTING SYSTEM
36 RICHMOND
ST. CROIX, VI

DATE:
OCT., 2024
REV:

SCALE:
1" = 20'
DRAWN BY:

JOB No.:
549
SHEET No.:

SP 1