



Original Festival Village Design





Original Festival Village Design








# Festival Village Option 1 2016/17





Festival Village Option 2 - 2016/17

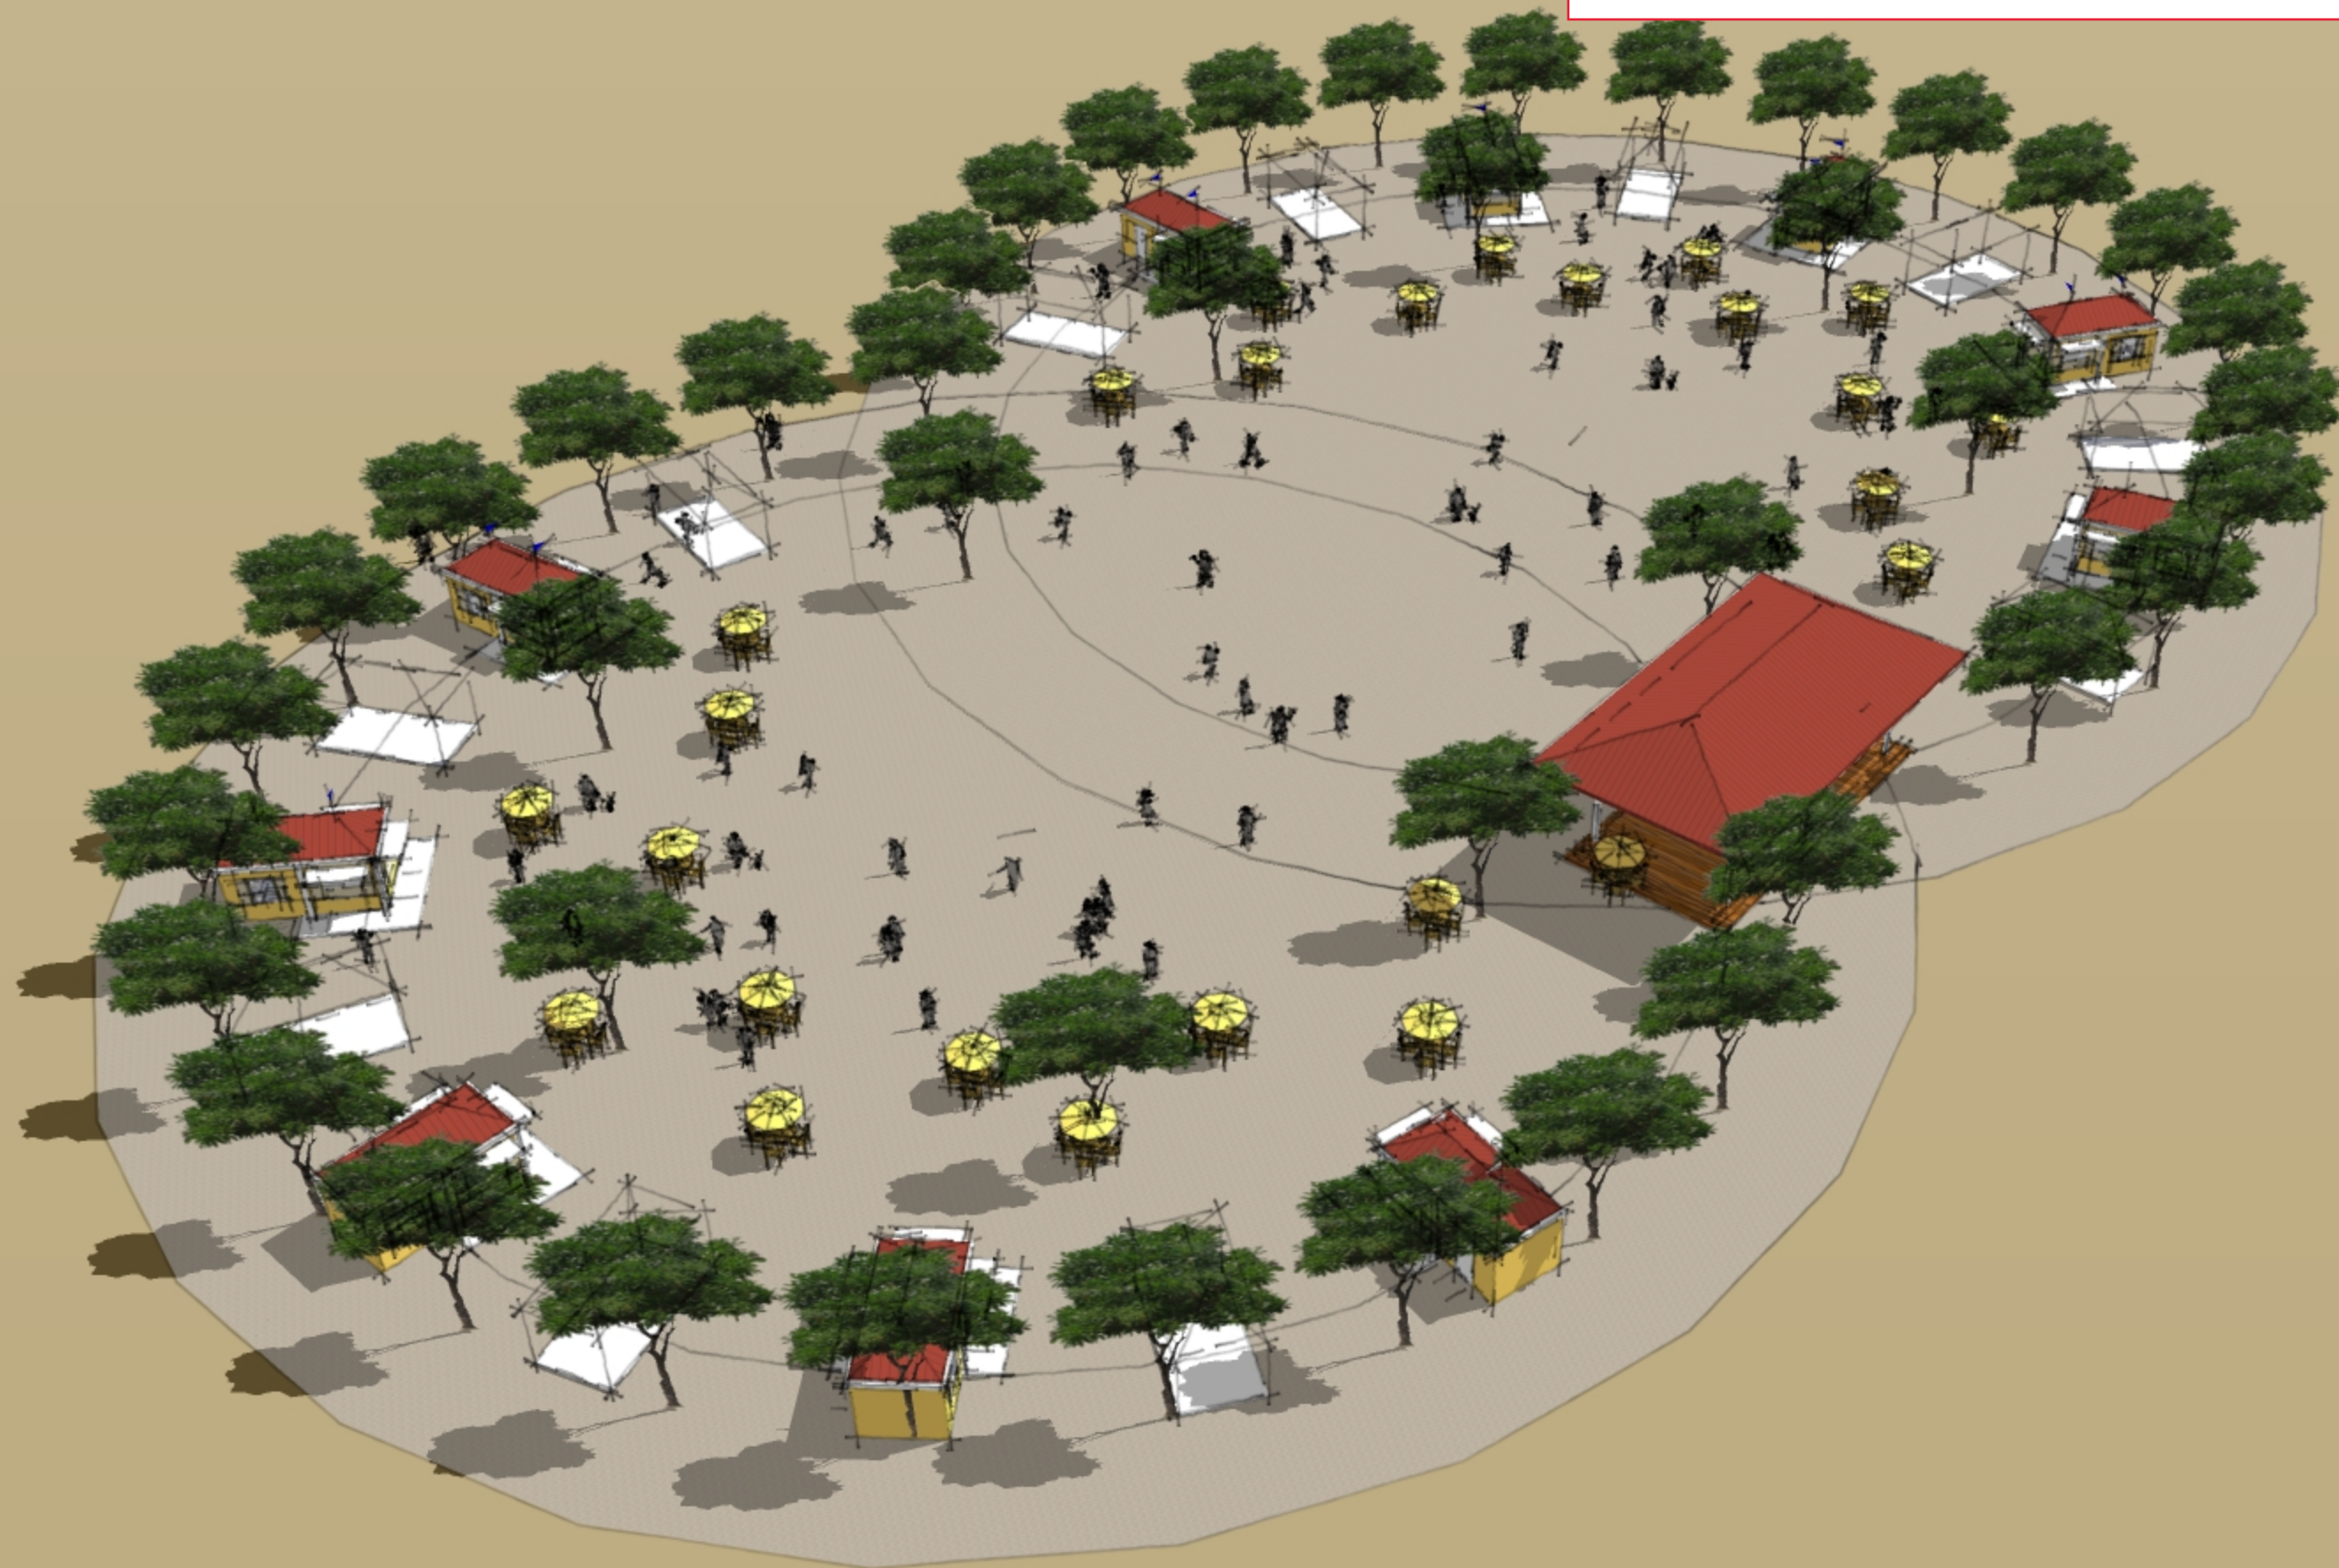




# Festival Village Option 3 - 2016/17






## Festival Village Option 4 - 2016/17

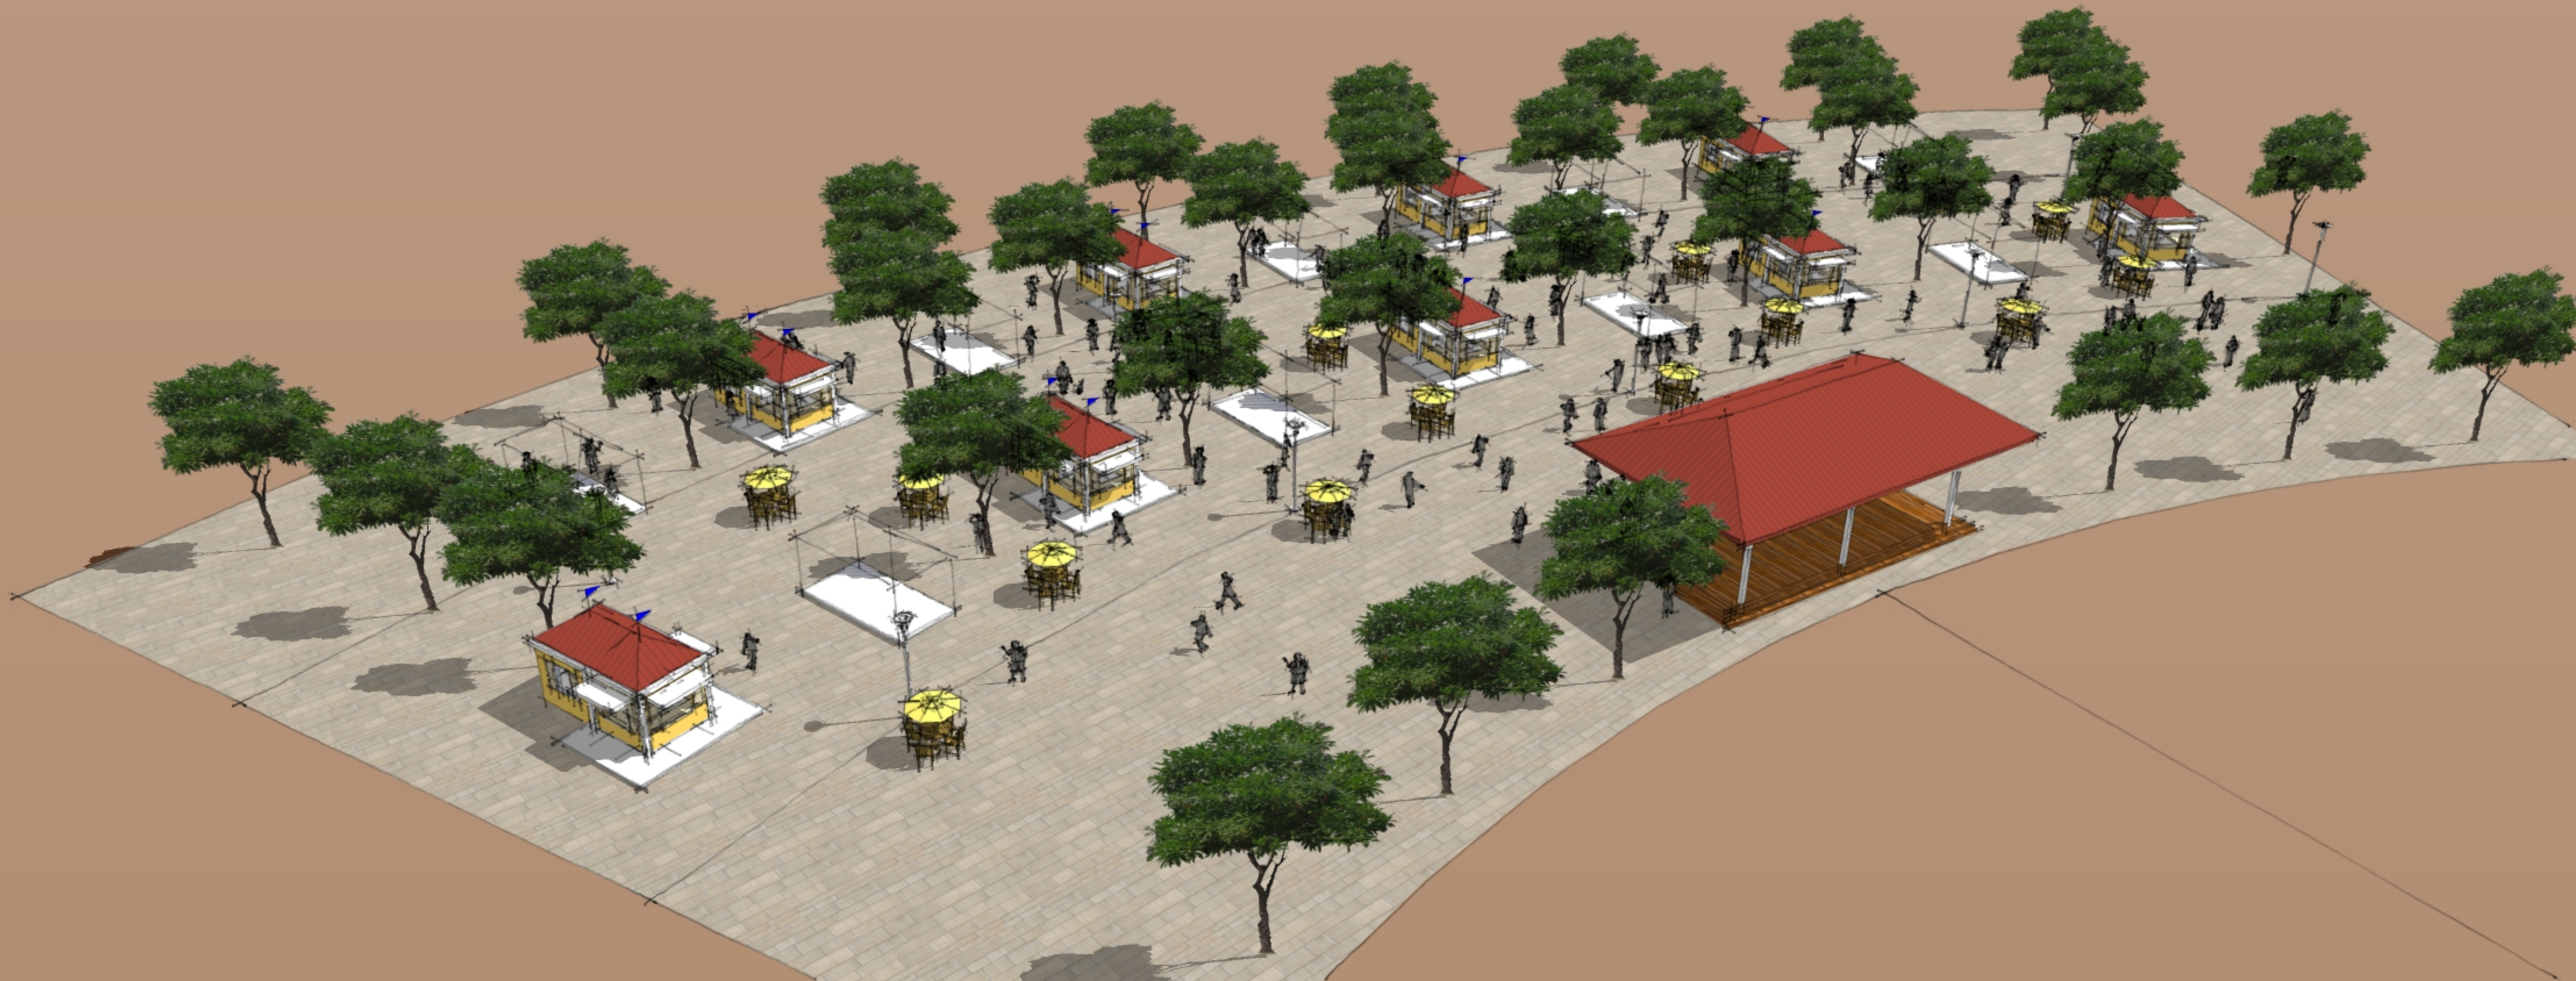




# Festival Village option 5 - 2016/17


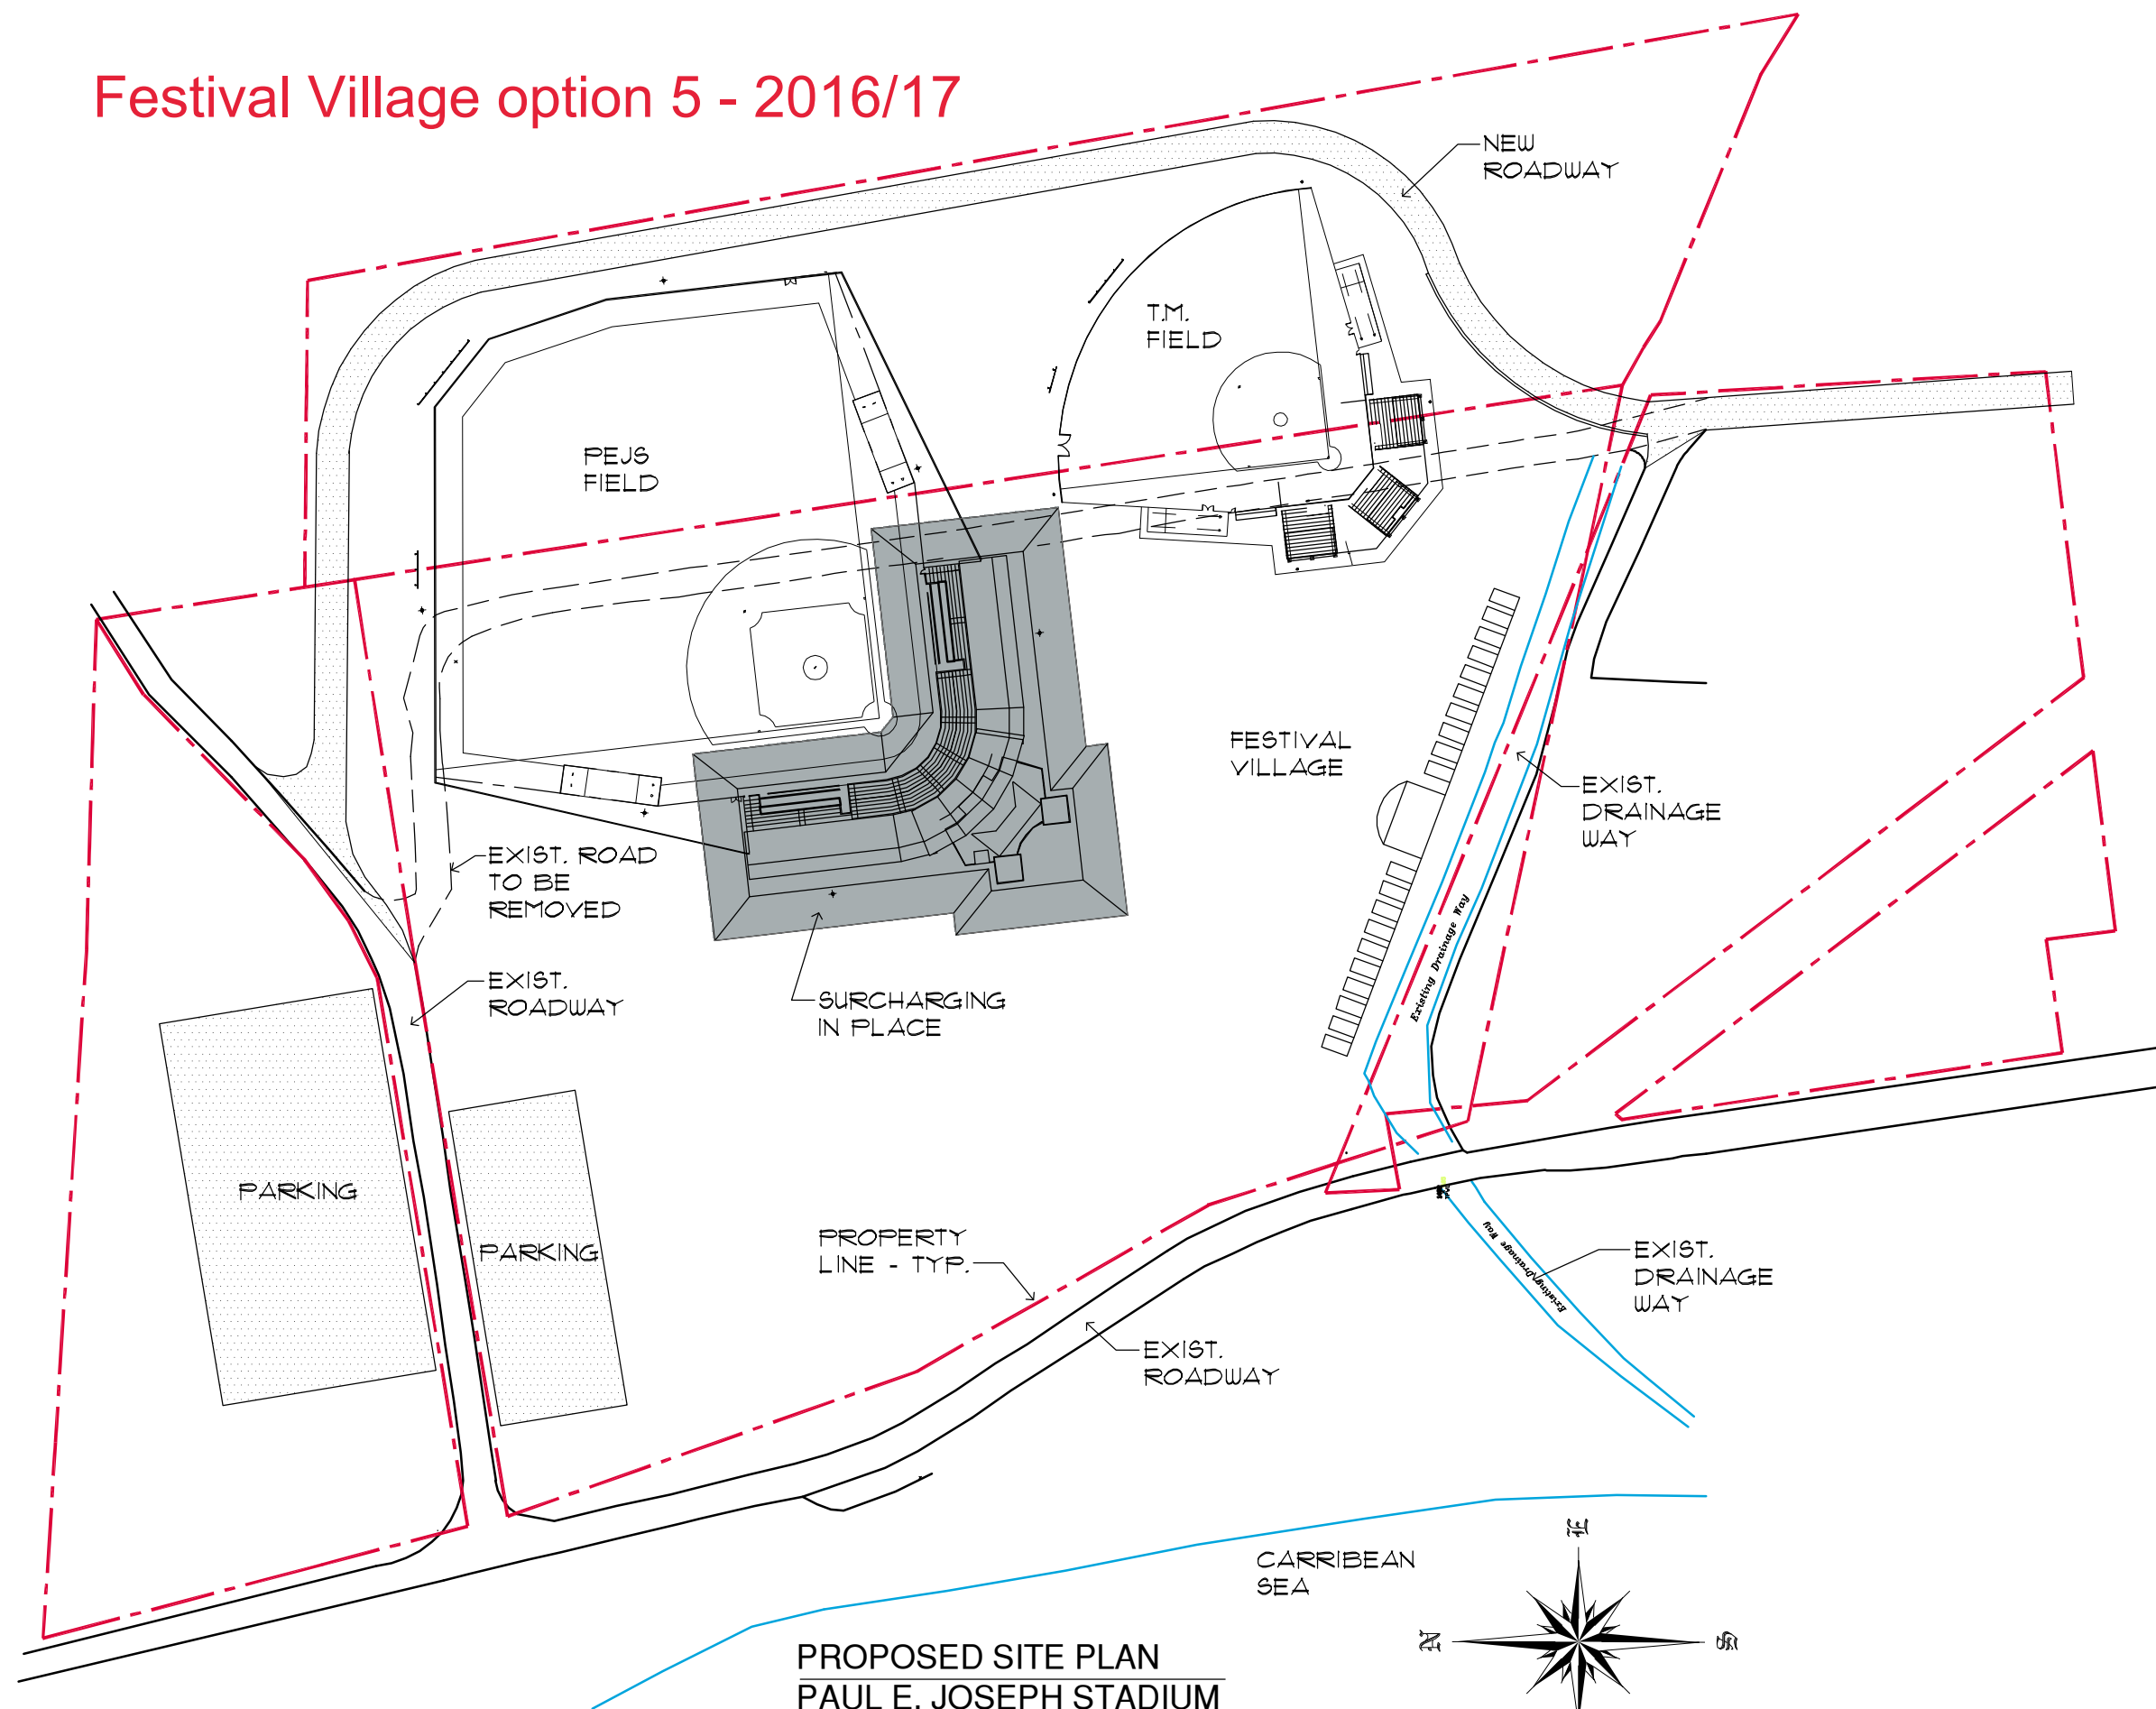


**PROPOSED SITE PLAN**  
**PAUL E. JOSEPH STADIUM**  
STEVEN E. HUTCHINS ARCHITECTS - OCTOBER 13, 2017

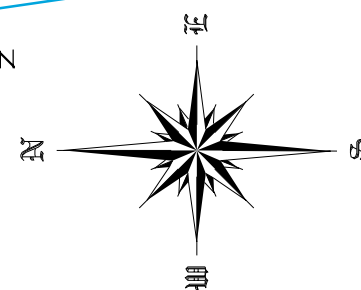





# Festival Village Option 6 - 2016/17

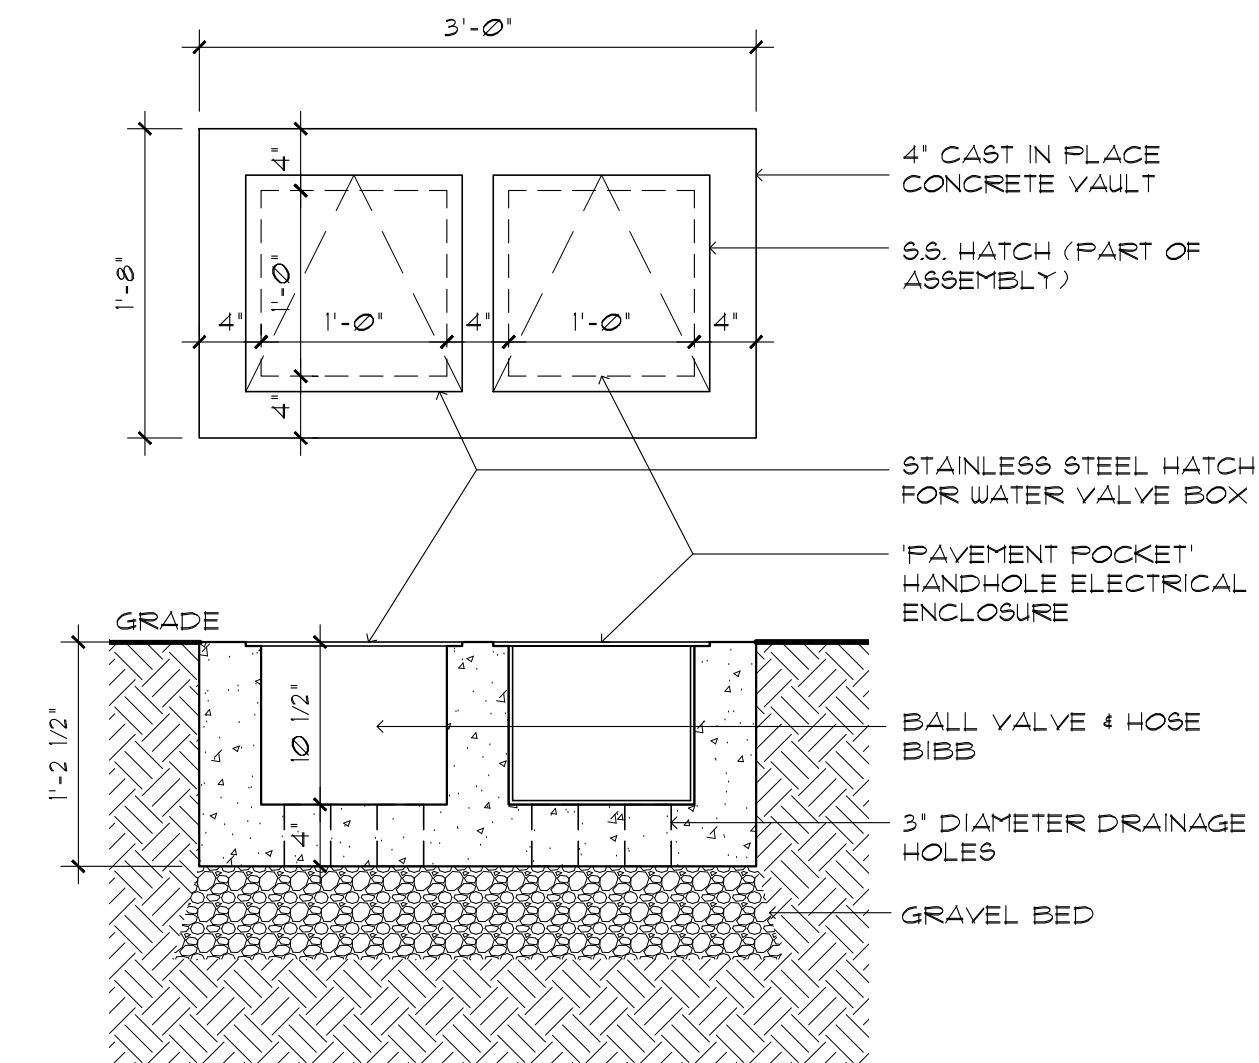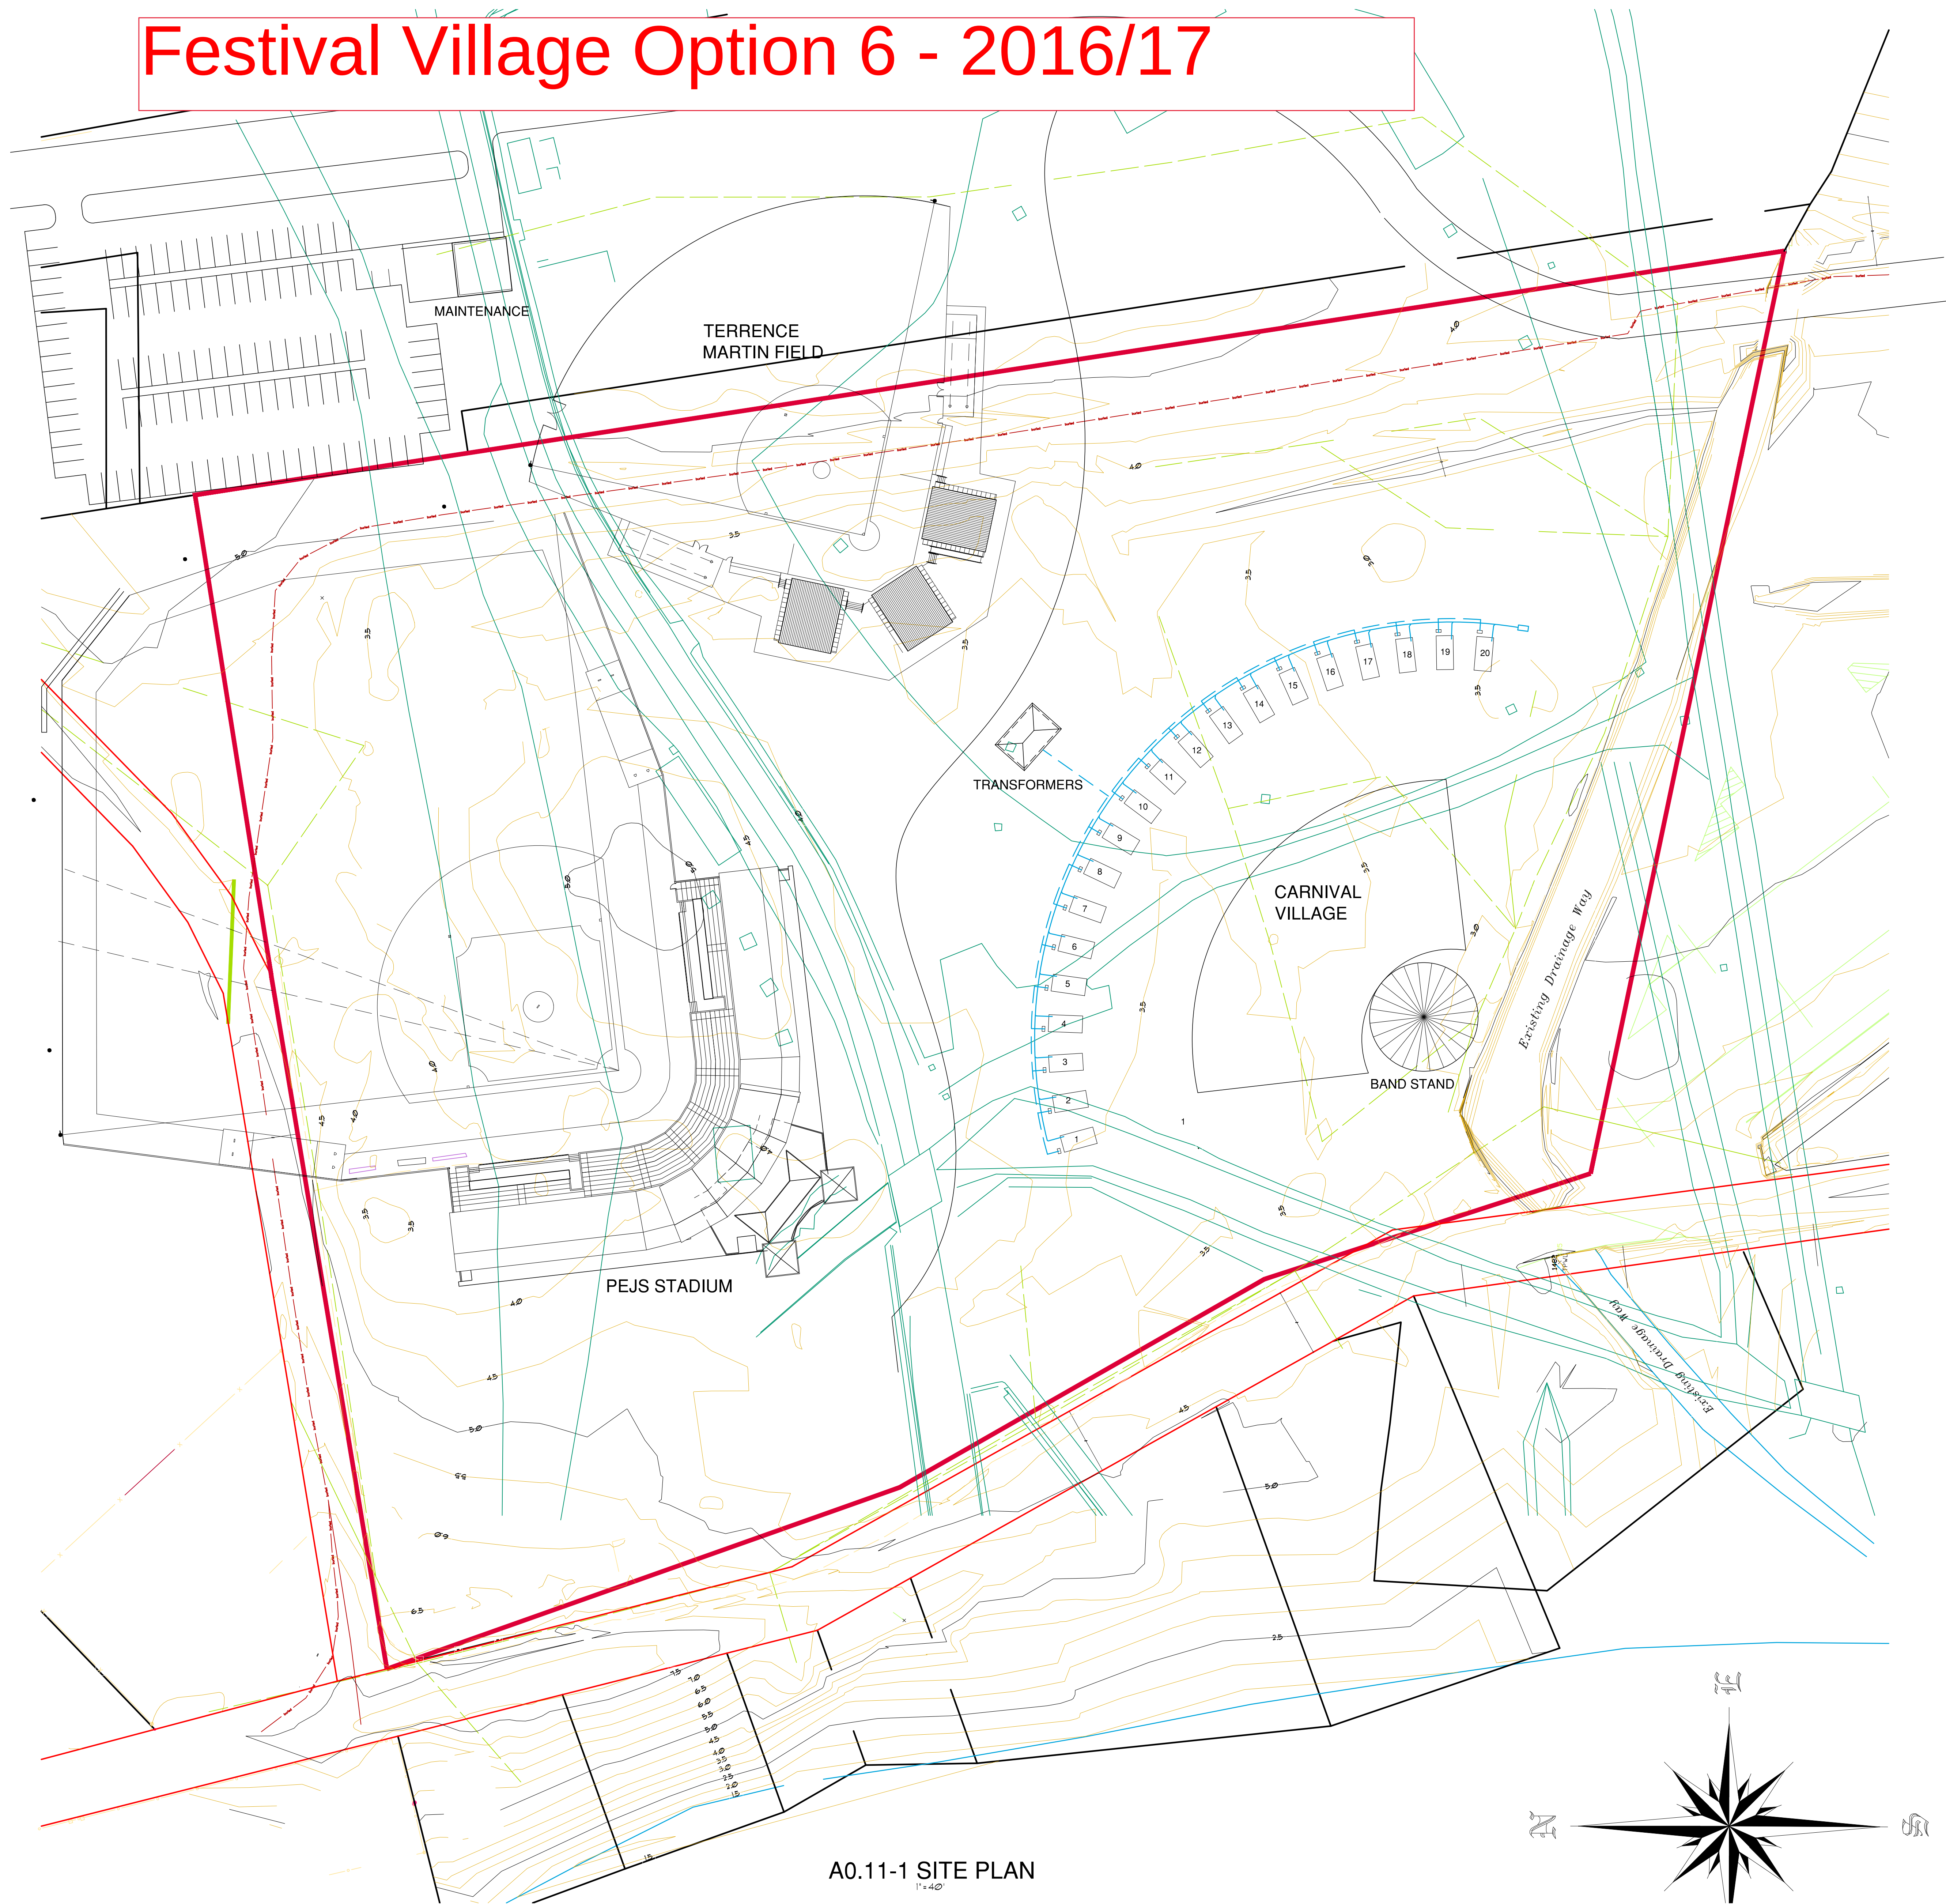

A0.11-3 POWER & WATER VAULT

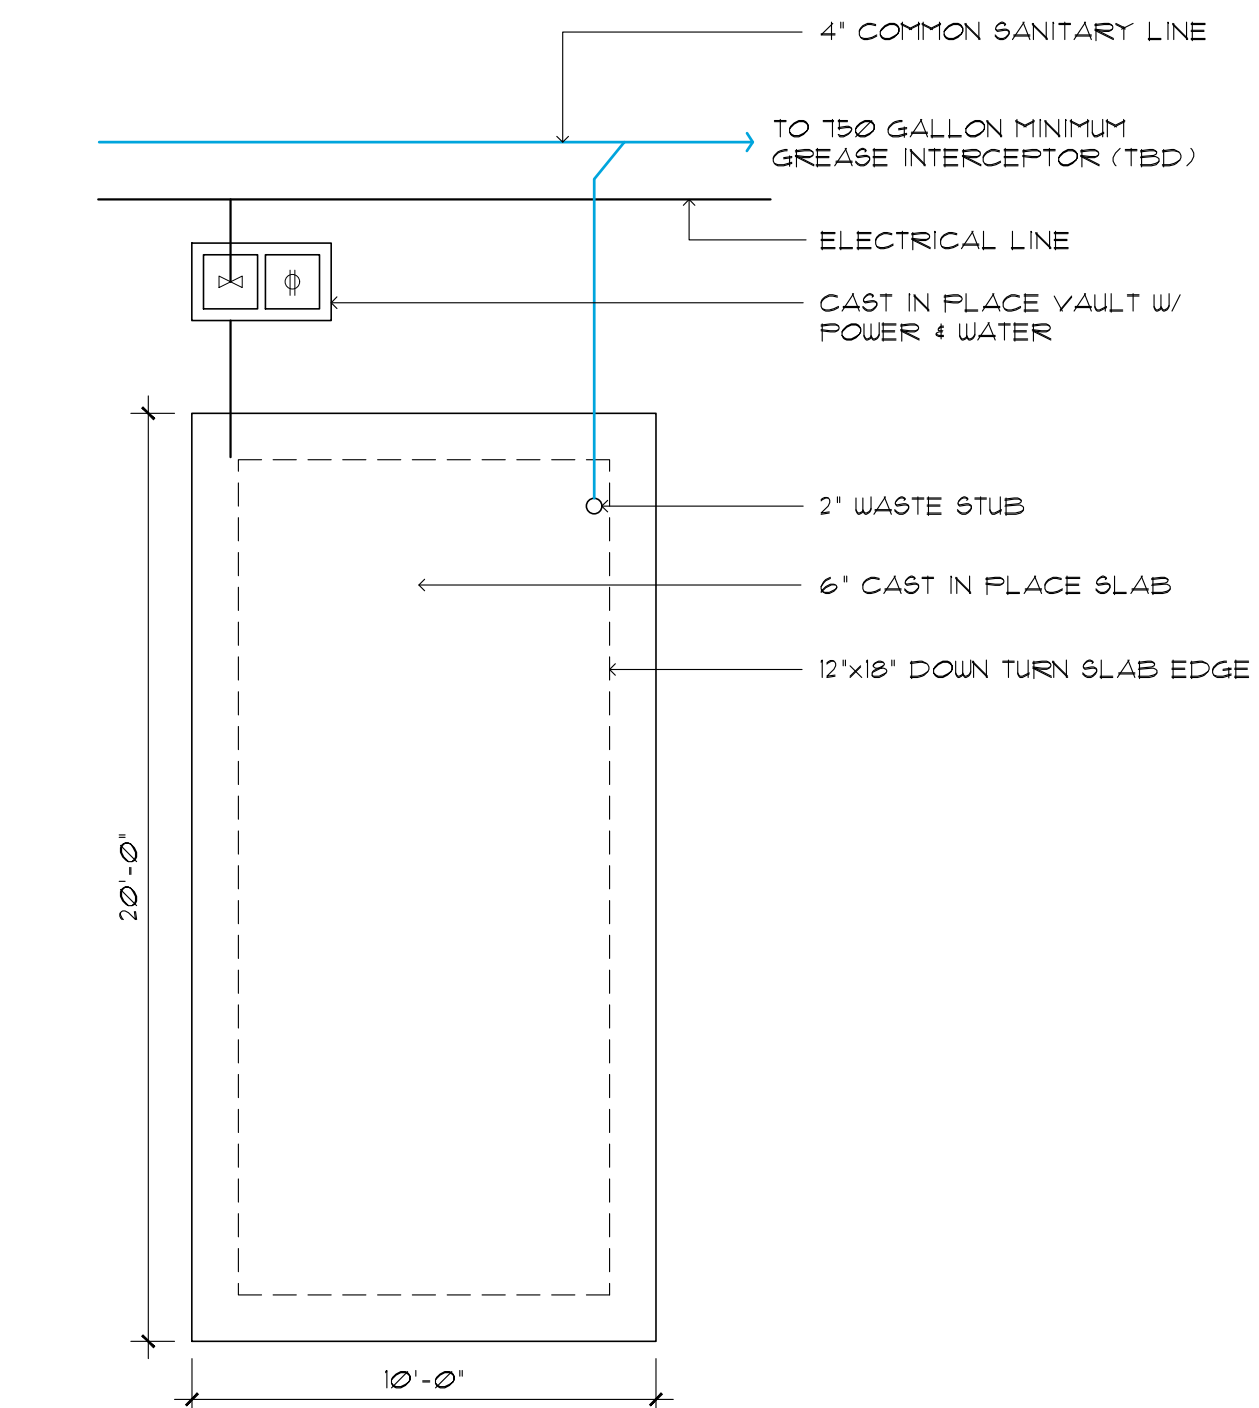

A0.11-3 TYPICAL VENDOR SLAB

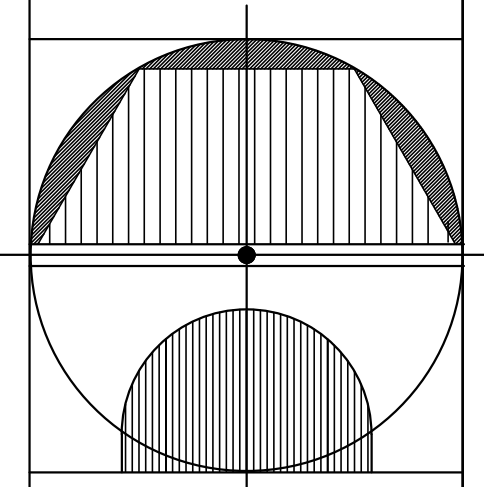

Steven E. Hutchins AIA Architects  
109-113 ESTATE CASTLE COAKLEY  
CHRISTIANSTED, ST. CROIX  
U.S. VIRGIN ISLANDS 00822  
TEL 340-778-8898 FAX 340-778-7754

PROJECT:  
FREDERIKSTED REVITALIZATION PROJECT  
PAUL E. JOSEPH BASEBALL STADIUM  
AND SPORT COMPLEX

DRAWING INFORMATION:  
CONCEPT SITE PLAN


DATE:  
DRAWN BY:

SHEET NUMBER:

A0.11



As discussed in the PEJ 7/2/19 Job Meeting

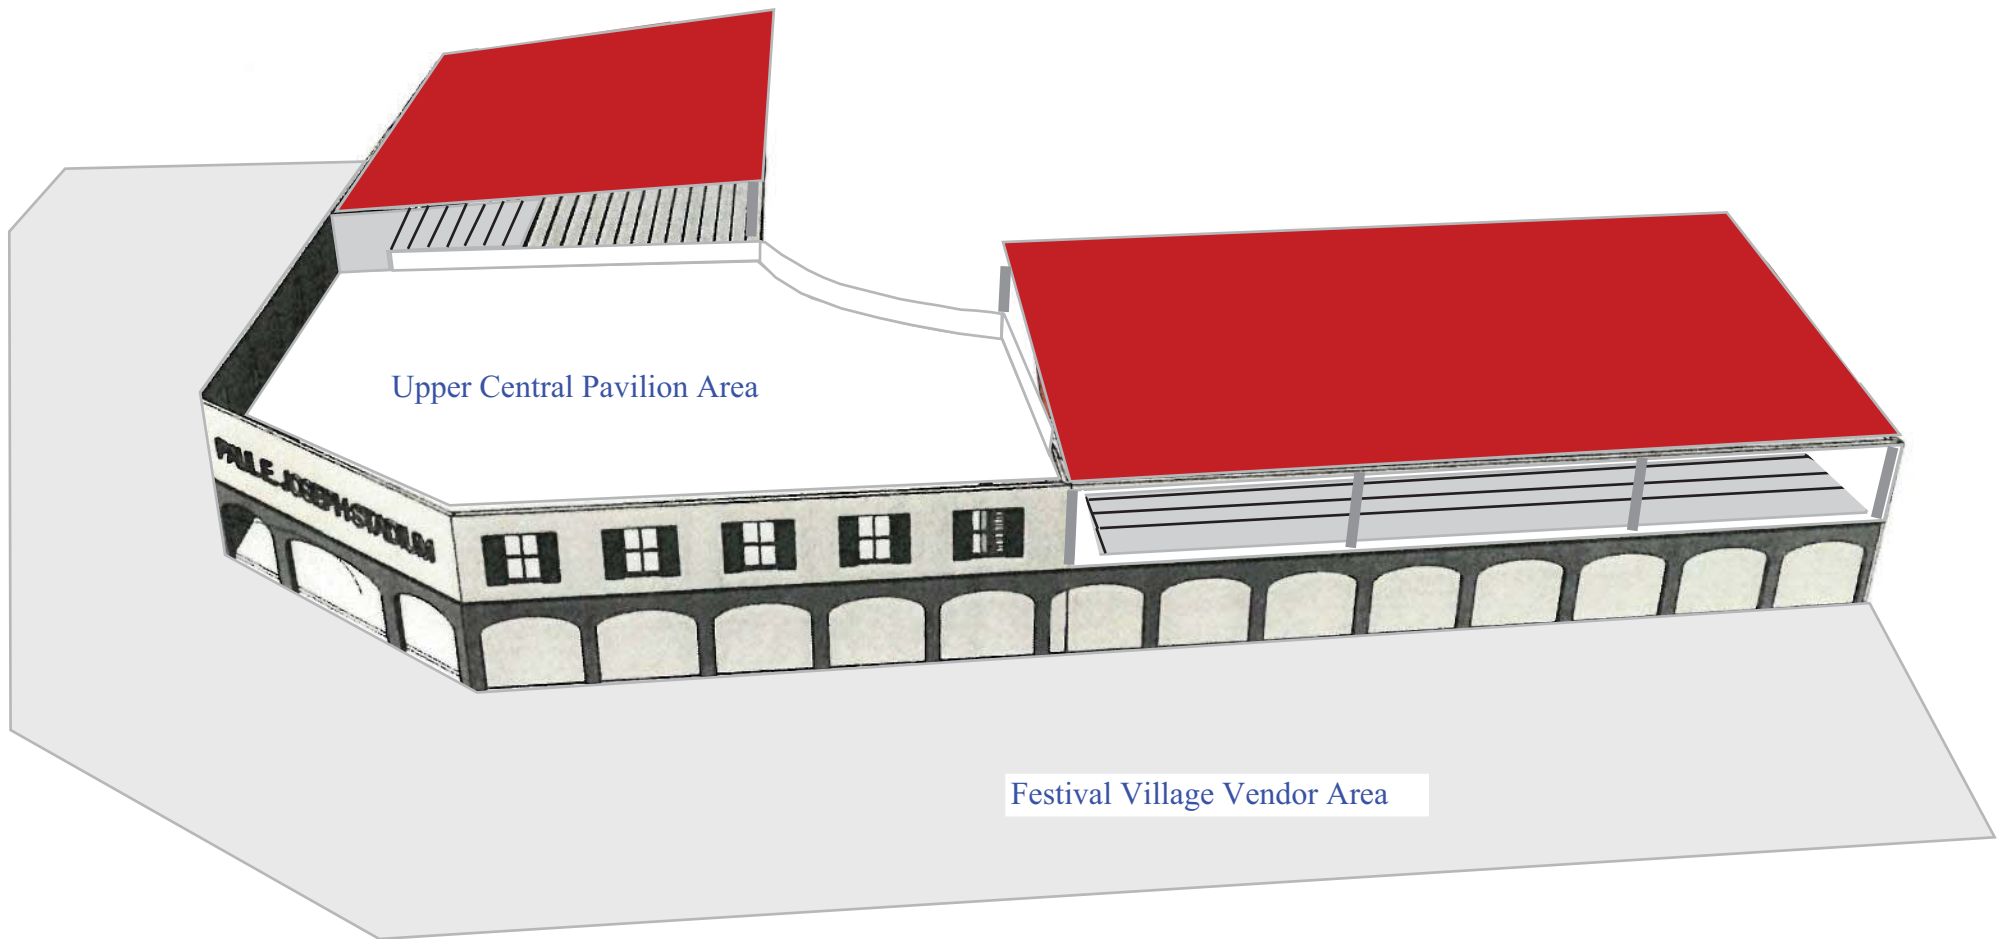



As discussed in the PEJ 7/2/19 Job Meeting

